


# LUMINAIRE SCHEDULE

Symbol	Label	Qty	Catalog Number	Description	Lamp	File	Lumens	LLF	Watts
□	A	60	IBZ 832	IBZ, 8-LAMP, 32W T8, NARROW DISTRIBUTION	8 32-WATT LINEAR FLOURESCENT T8,	IBZ_832.ies	2800	0.85	293

# STATISTICS

Description	Symbol	Avg	Max	Min	Max/Min	Avg/Min
CALCULATIONS	+	104 fc	124 fc	63 fc	2.0:1	1.7:1

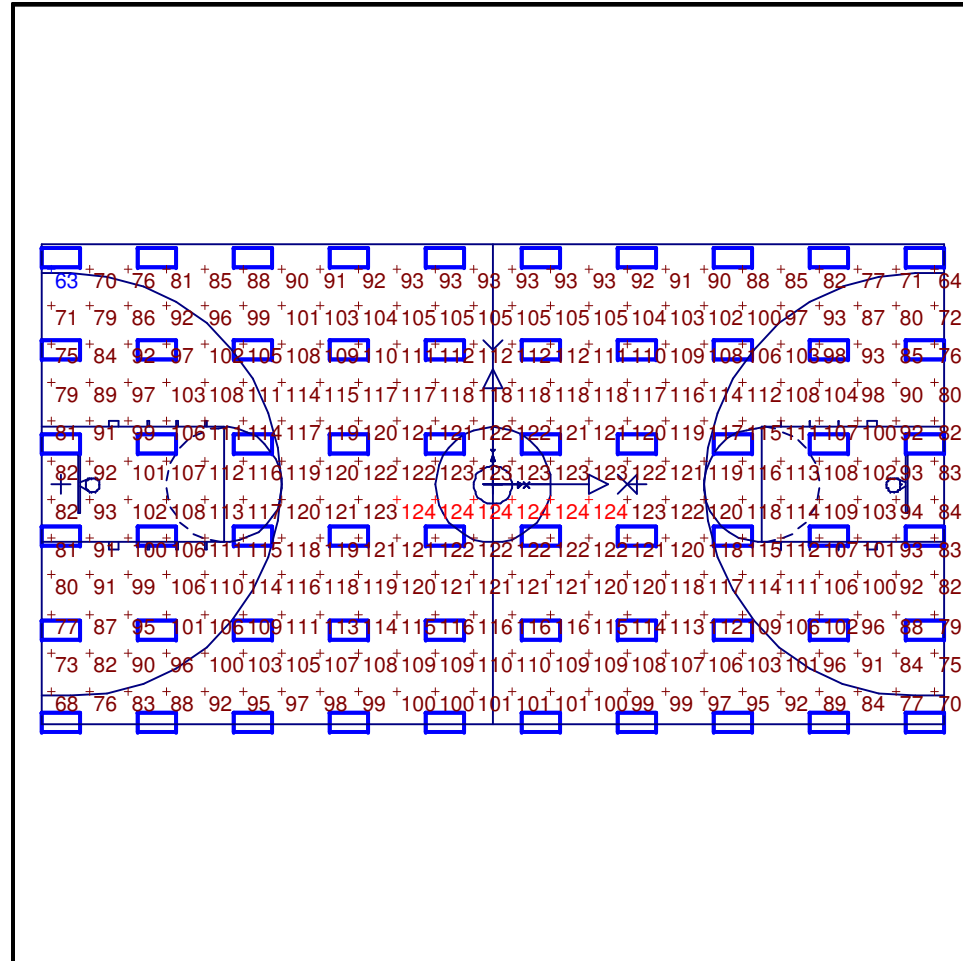

# NOTES

1. FIXTURE MOUNTING HEIGHT 24.0 FEET.

Plan View

Scale 1" = 20'



**LITHONIA LIGHTING**

An Acuity Brands Company

**LIGHTING TECHNOLOGY**

lighting.tech@lithonia.com

One Lithonia Way

Conyers, GA 30012

P: (800) 279-8043

F: (770) 929-3625

BASKETBALL  
IBZ 832  
100 FOOTCANDLES

**Designer**

R.A. MCILRATH

**Date**

MARCH 31, 2010

**Scale**

AS NOTED

**Drawing No.**

999-02410G6

1 of 1