



LITHONIA LIGHTING


An Acuity Brands Company

LIGHTING TECHNOLOGY


lighting.tech@lithonia.com

One Lithonia Way
Conyers, GA 30012
P: (800) 279-8043
F: (770) 929-3625

Typical School Lot
AERIS 400m
30' Mounting Height

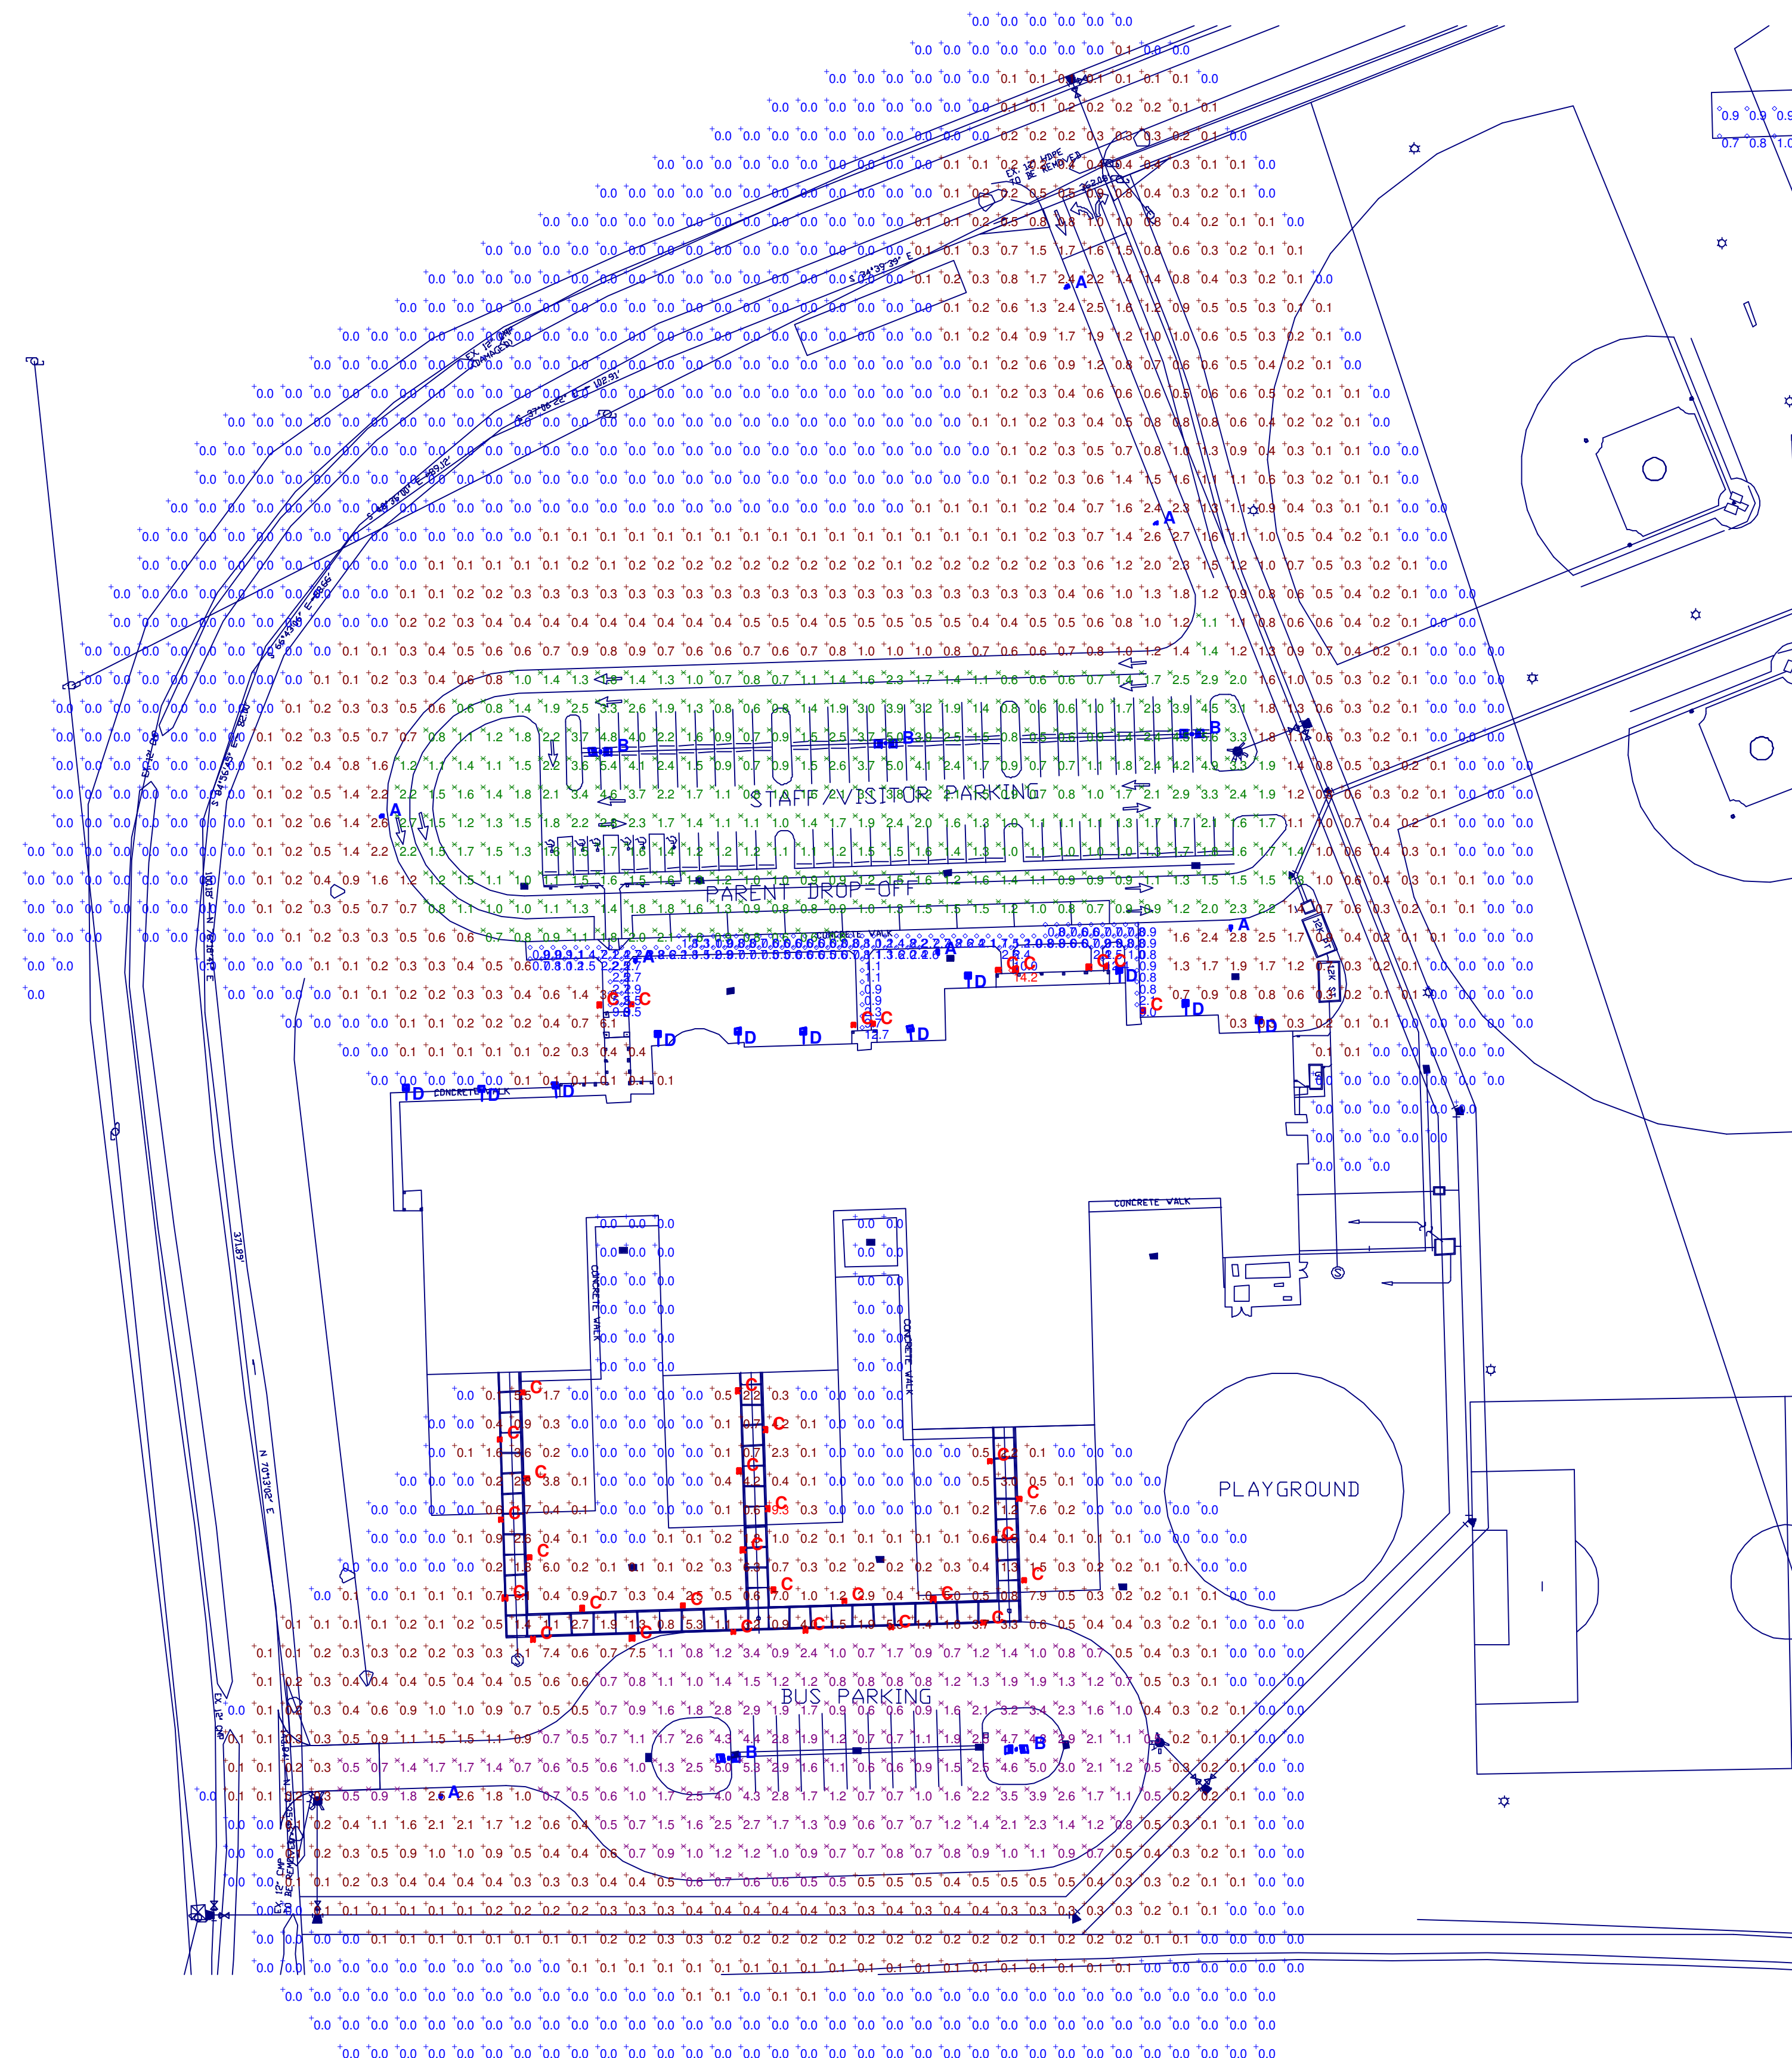

Plan View
Scale 1" = 60'

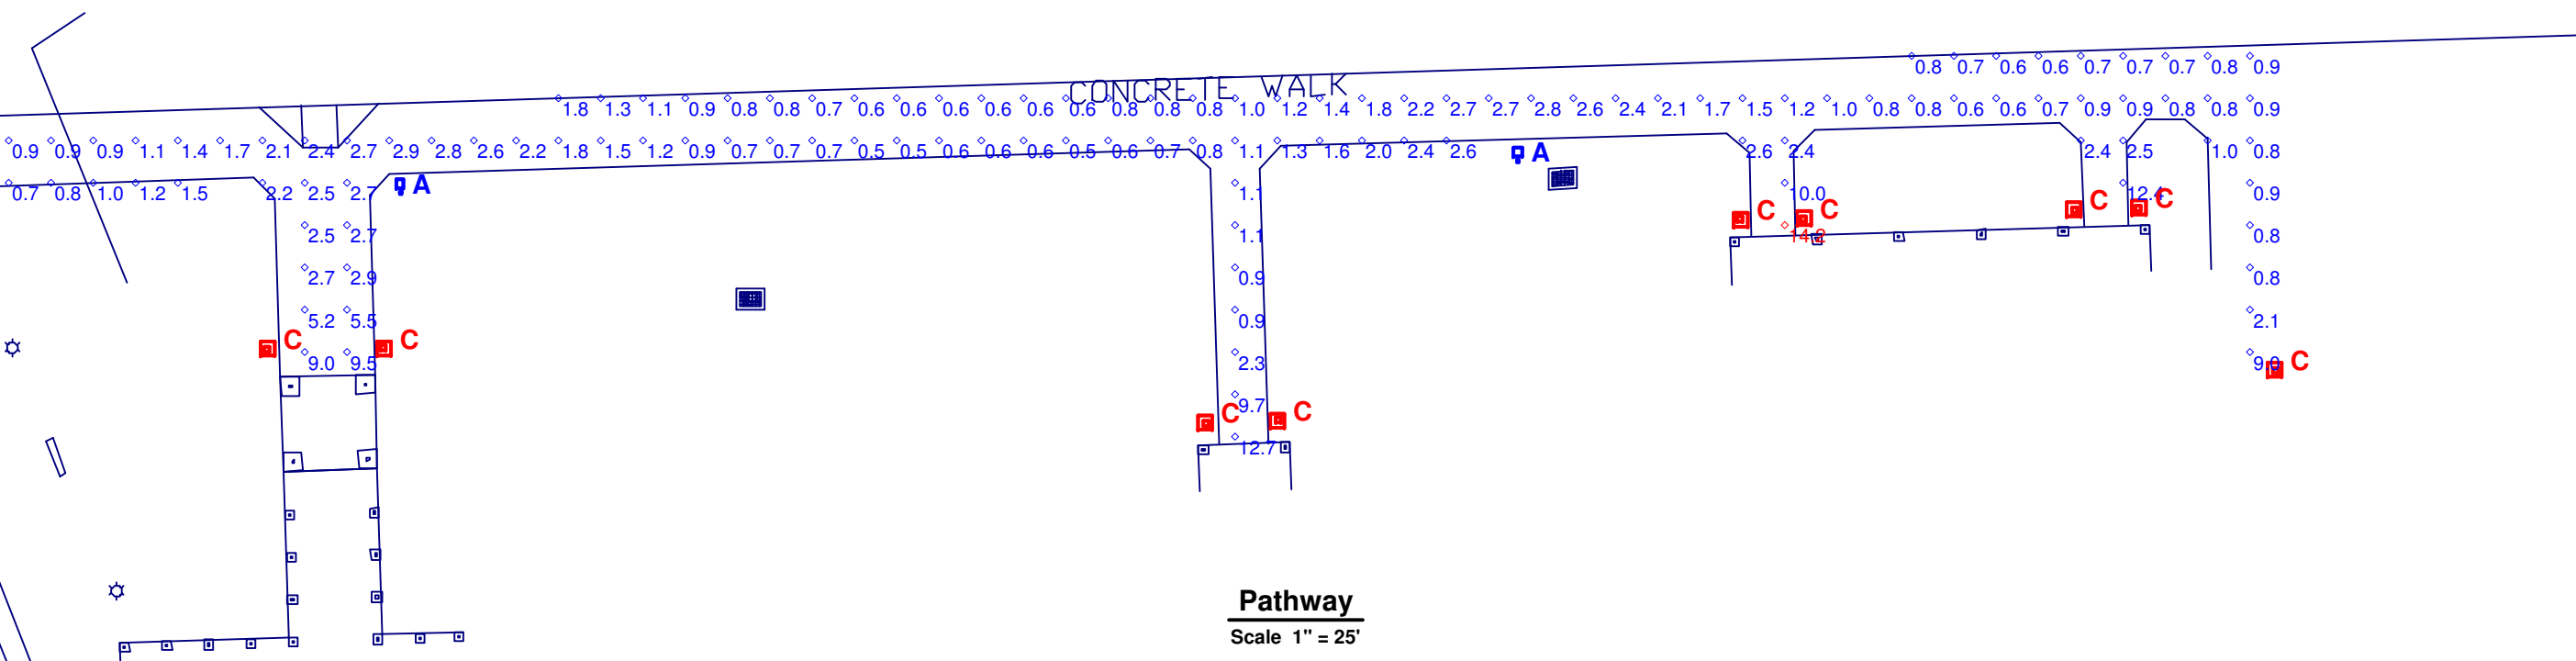

Pathway
Scale 1" = 25'

NOTES

1. Refer to luminaire schedule for total LLF.
2. Please refer to the "luminaire locations" table for mounting heights.
3. Product information can be obtained at www.Lithonia.com or through your local agency.

STATISTICS

Description / Parking Area	Symbol	Avg	Max	Min	Max/Min	Avg/Min
Bus Loading / Parking Area	X	1.5 fc	5.3 fc	0.5 fc	10.6:1	3.0:1
Front Walkway	◇	2.0 fc	14.2 fc	0.5 fc	28.4:1	4.0:1
Spill Light Summary	+	0.6 fc	9.3 fc	0.0 fc	N / A	N / A
Staff/Visitor Parking	X	1.7 fc	5.6 fc	0.5 fc	11.2:1	3.4:1

LUMINAIRE SCHEDULE

Symbol	Label	Qty	Catalog Number	Description	Lamp	File	Lumens	LLF	Watts
□	A	7	AS2 400M SR4W SCWA	ARCHITECTURAL ARM-MOUNTED CUTOFF LUMINAIRE WITH SR4W REFLECTOR. Meets the 'NIGHTTIME FRIENDLY' Criteria	MS400W/H75/ED28/PS	LtI10101.jes	31000	0.75	462
■	B	5	AS2 400M SR4W SCWA	ARCHITECTURAL ARM-MOUNTED CUTOFF LUMINAIRE WITH SR4W REFLECTOR. Meets the 'NIGHTTIME FRIENDLY' Criteria	MS400W/H75/ED28/PS	LtI10101.jes	31000	0.75	924
□	C	35	ASBX 70M R5 TB LPI	SQUARE ACRYLIC LENS, UPPER SEMI-SPECULAR ALUM REFLECTOR, LOWER SEMI-SPECULAR ALUM REFLECTOR	ONE 70-WATT COATED E17 METAL HALIDE, VERTICAL BASE DOWN POS.	LTL14580.IES	5100	0.75	129
■	D	11	ASF1 100M MF	AERIS FLOOD LUMINAIRE, 100-WATT METAL HALIDE, MEDIUM FLOOD	ONE 100-WATT CLEAR E17 METAL HALIDE, HORIZONTAL POS.	LtI14920P.jes	8100	0.75	211

Designer

Date

Scale

1" = 40'

Drawing No.

AER40M30