



**LITHONIA
LIGHTING**


An **AcuityBrands** Company

**LIGHTING
TECHNOLOGY**


lighting.tech@lithonia.com

One Lithonia Way
Conyers, GA 30012
P: (800) 279-8043
F: (770) 929-3625

Typical School Lot
KVF 400m
30' Mounting Height

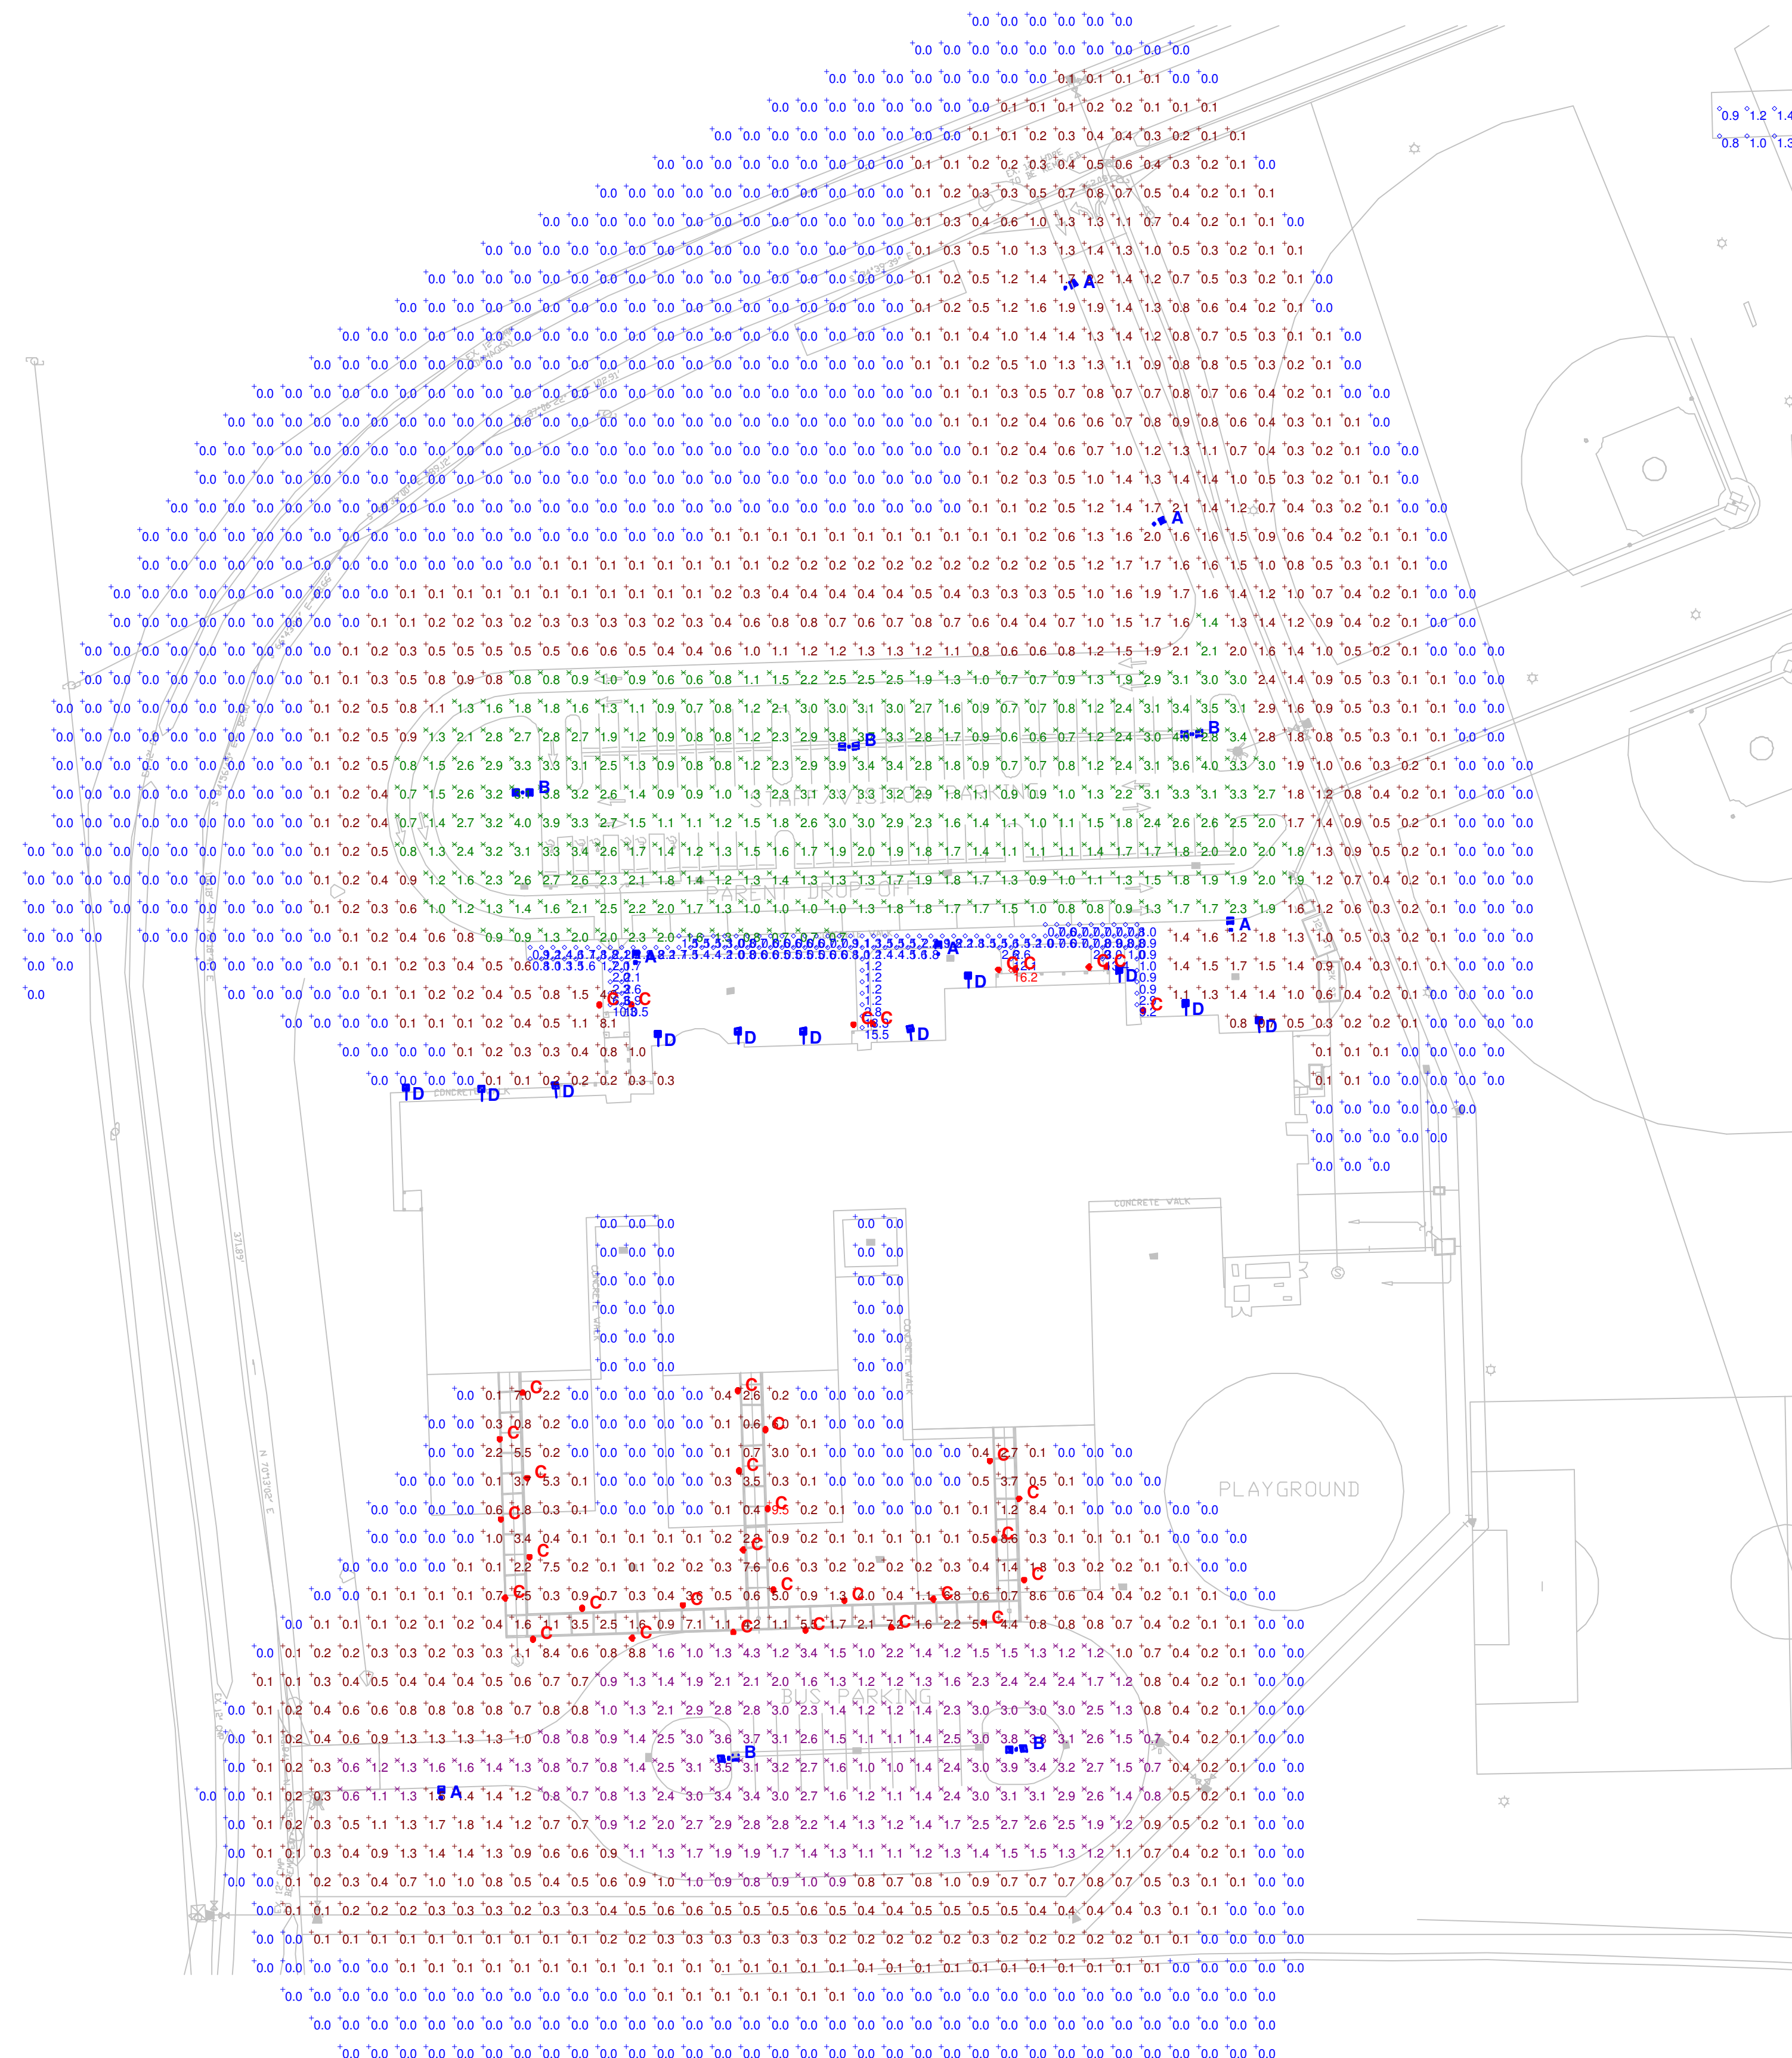

Plan View
Scale 1" = 60'

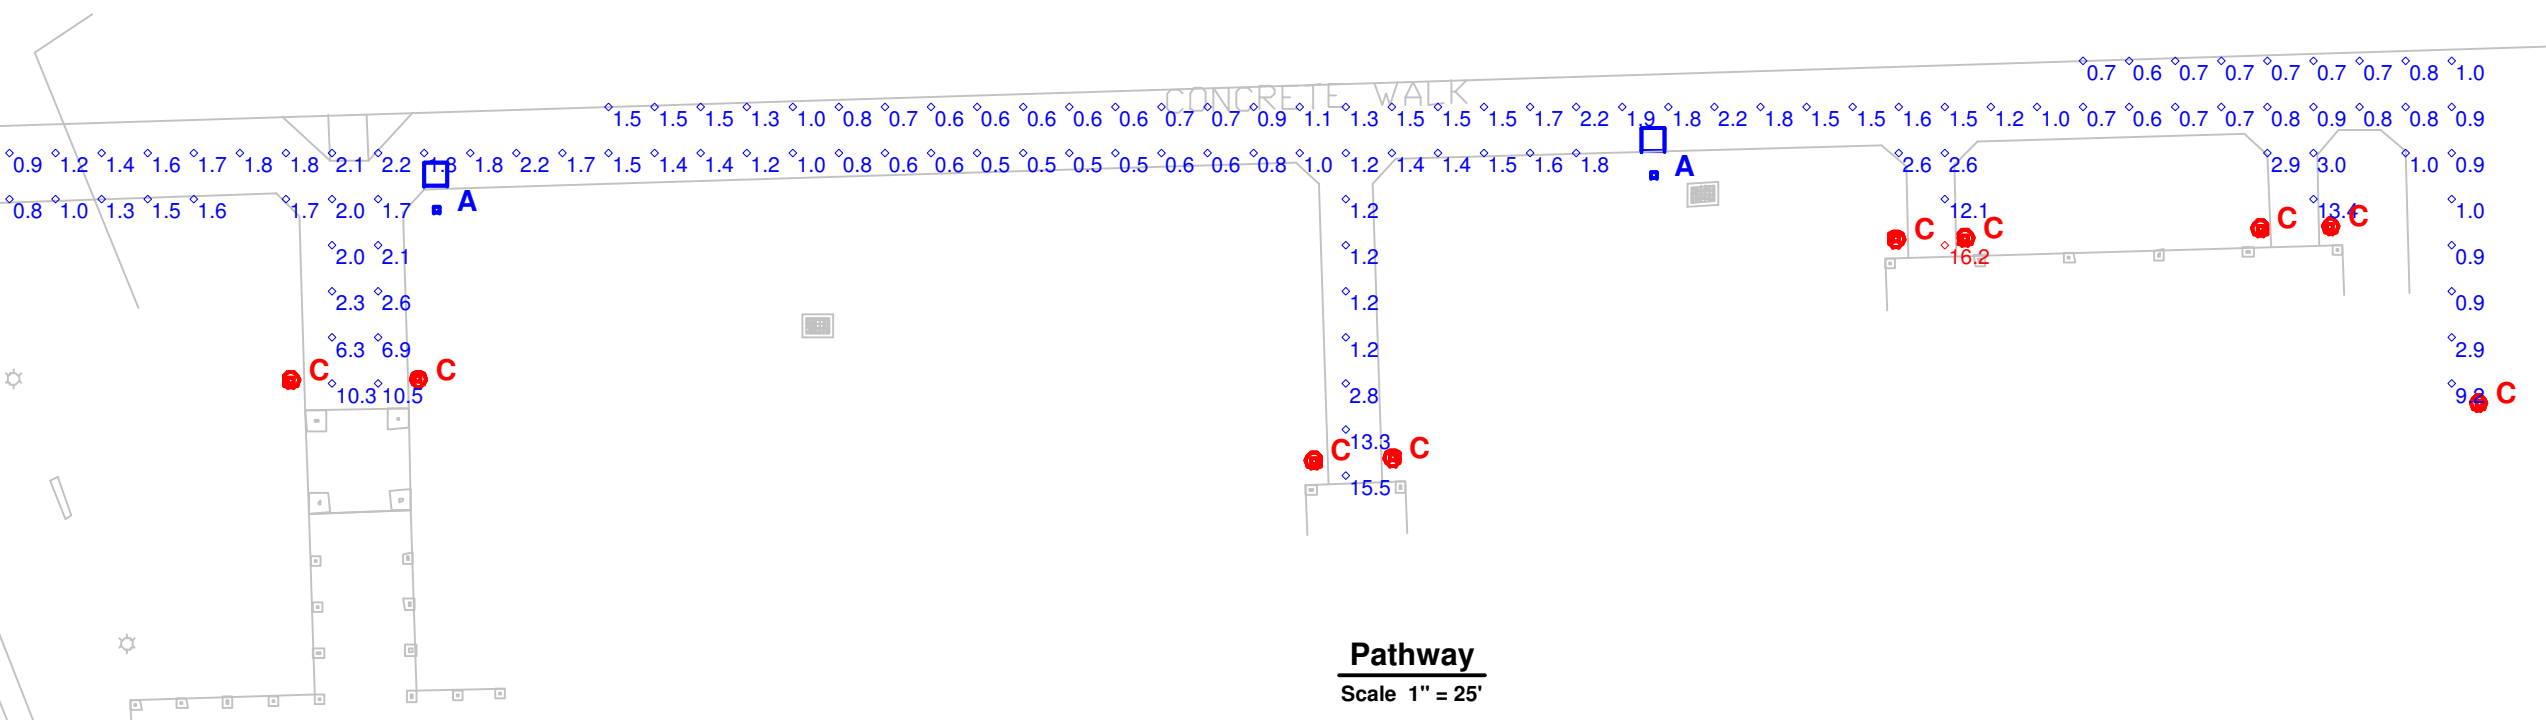

Pathway
Scale 1" = 25'

NOTES

1. Refer to luminaire schedule for total LLF.
2. Please refer to the "luminaire locations" table for mounting heights.
3. Product information can be obtained at www.Lithonia.com or through your local agency.

STATISTICS

Description	Symbol	Avg	Max	Min	Max/Min	Avg/Min
Bus Loading / Parking Area	X	1.9 fc	4.3 fc	0.6 fc	7.2:1	3.2:1
Front Walkway	◇	2.1 fc	16.2 fc	0.5 fc	32.4:1	4.2:1
Spill Light Summary	+	0.7 fc	9.5 fc	0.0 fc	N / A	N / A
Staff/Visitor Parking	X	1.9 fc	4.0 fc	0.6 fc	6.7:1	3.2:1

LUMINAIRE SCHEDULE

Symbol	Label	Qty	Catalog Number	Description	Lamp	File	Lumens	LLF	Watts
□	A	6	KVF2 400M ASYFL	SQUARE AREA LIGHT, SYMMETRIC DISTRIBUTION, FLAT LENS. Meets the 'NIGHTTIME FRIENDLY' Criteria	400M/BU/PS	LI19433A.ies	44000	0.75	462
■	B	5	KVF2 400M SYMFL	SQUARE AREA LIGHT, SYMMETRIC DISTRIBUTION, FLAT LENS. Meets the 'NIGHTTIME FRIENDLY' Criteria	400M/BU/PS	LI19432A.ies	44000	0.75	924
⊙	C	35	KBR8 70M R5	8 IN ROUND BOLLARD	ONE 70-WATT CLEAR E-17 METAL HALIDE, VERTICAL BASE-DOWN POSITION.	94033003.IES	5100	0.75	95
▢	D	11	TFM 100M RB	SPECIFICATION FLOODLIGHT, RB DISTRIBUTION, 100W MH, W/ CLEAR LAMP. Meets the 'NIGHTTIME FRIENDLY' Criteria	ONE 100-WATT CLEAR ED-17 METAL HALIDE, HORIZONTAL POSITION.	97061313.IES	8500	0.75	140

Designer

Date

Scale

1" = 40'

Drawing No.

KVF40M30