

LUMINAIRE SCHEDULE									
Symbol	Label	Qty	Catalog Number	Description	Lamp	File	Lumens	LLF	Watts
•	A	5	325 40S R2 DG	325 SERIES 400W HPS TYPE 2 MED SEMI CUTOFF	ONE 400-WATT HIGH PRESSURE SODIUM.	AE7370.IES	50000	0.81	930

STATISTICS						
Description	Symbol	Avg	Max	Min	Max/Min	Avg/Min
CALCS	+	2.1 fc	6.6 fc	0.8 fc	8.3:1	2.6:1


**NOTES**  
 1. FIXTURE MOUNTING HEIGHT 50.0 FEET.  
 2. FIXTURE ARM IS 4 FEET.

LUMINAIRE LOCATIONS										
No.	Label	Location			MH	Orientation	Tilt	X	Aim	
		X	Y	Z					Y	Z
1	A	0.0	26.0	50.0	50.0	0.0	0.0			
2	A	275.0	26.0	50.0	50.0	0.0	0.0			
3	A	550.0	26.0	50.0	50.0	0.0	0.0			
4	A	825.0	26.0	50.0	50.0	0.0	0.0			
5	A	1100.0	31.0	50.0	50.0	0.0	0.0			



**LITHONIA  
LIGHTING**  
 An Acuity Brands Company

**LIGHTING  
TECHNOLOGY**  
 lighting.tech@lithonia.com  
 One Lithonia Way  
 Conyers, GA 30012  
 P: (800) 279-8043  
 F: (770) 929-3625

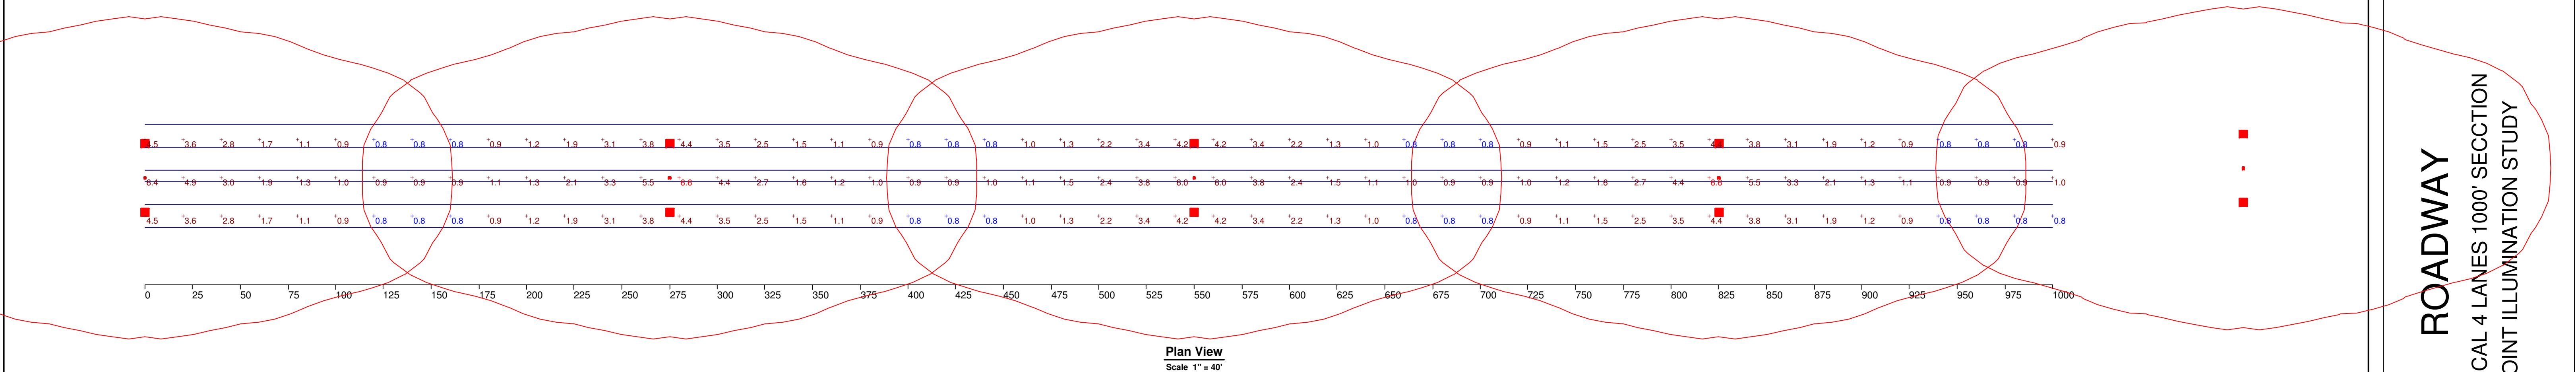

**Plan View**  
 Scale 1" = 40'

**ROADWAY**  
 TYPICAL 4 LANES 1000' SECTION  
 POINT ILLUMINATION STUDY

**Designer**  
 R.A. MCILRATH

**Date**  
 Oct 22, 2009

**Scale**  
 AS NOTED

**Drawing No.**  
 999-03609C20