

LUMINAIRE SCHEDULE									
Symbol	Label	Qty	Catalog Number	Description	Lamp	File	Lumens	LLF	Watts
■	A	5	MC400HP00NFXGX	MONGOOSE	400W CLEAR HPS	49257.ies	50000	0.81	2
■			NARROW ROADWAY,FLAT GLASS,0TILT						


STATISTICS						
Description	Symbol	Avg	Max	Min	Max/Min	Avg/Min
ROADWAY	+	2.6 fc	7.9 fc	0.9 fc	8.8:1	2.9:1

NOTES
1. FIXTURE MOUNTING HEIGHT 40.0 FEET.

LUMINAIRE LOCATIONS										
No.	Label	Location			MH	Orientation	Tilt	Aim		
		X	Y	Z				X	Y	Z
1	A	0.0	39.0	40.0	40.0	0.0	0.0			
2	A	240.0	39.0	40.0	40.0	0.0	0.0			
3	A	480.0	39.0	40.0	40.0	0.0	0.0			
4	A	720.0	39.0	40.0	40.0	0.0	0.0			
5	A	960.0	39.0	40.0	40.0	0.0	0.0			



LIGHTING TECHNOLOGY
lighting.tech@lithonia.com
One Lithonia Way
Conyers, GA 30012
P: (800) 279-8043
F: (770) 929-3625

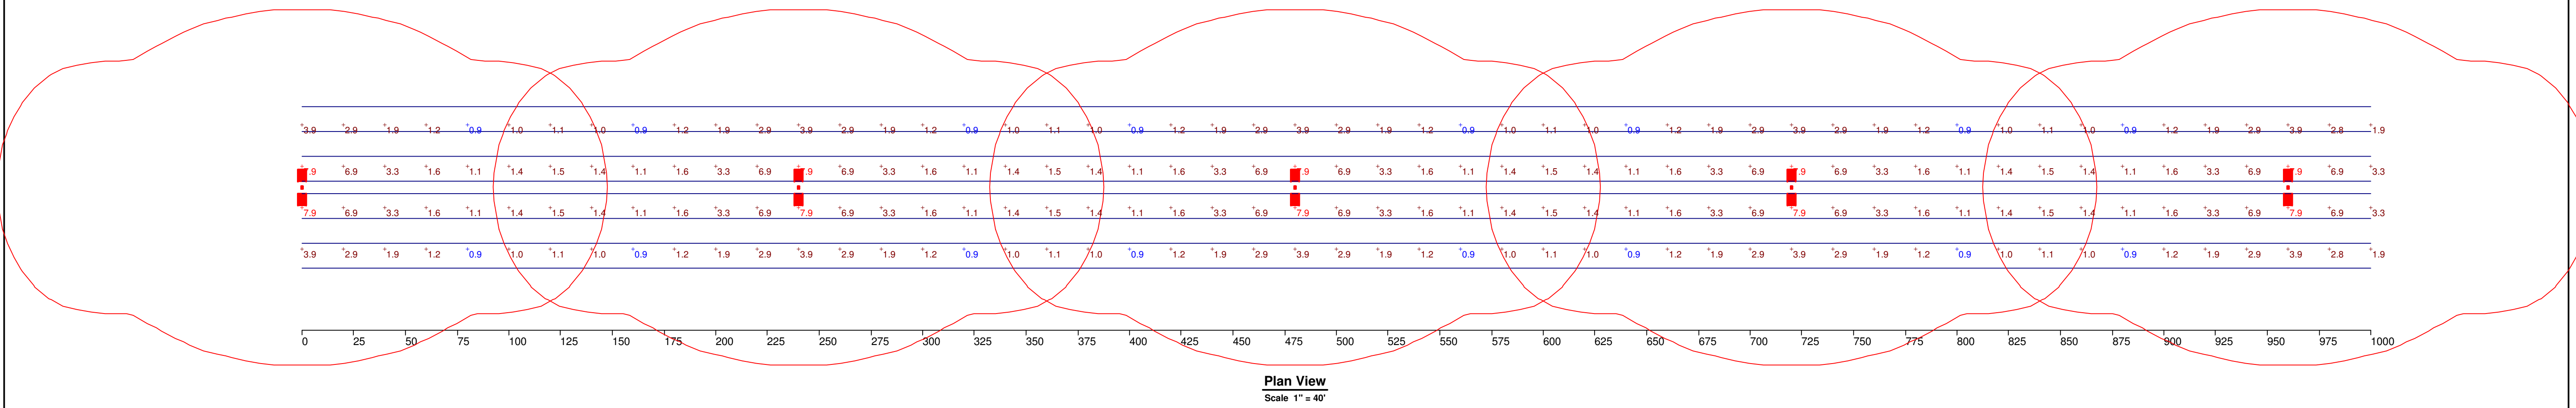

ROADWAY
TYPICAL 6 LANES 1000' SECTION
POINT ILLUMINATION STUDY

Designer
R.A. MCILRATH

Date
JAN. 7, 2010

Scale
AS NOTED

Drawing No.
999-03609E1