

LUMINAIRE SCHEDULE									
Symbol	Label	Qty	Catalog Number	Description	Lamp	File	Lumens	LLF	Watts
■	A	7	TDR 400M R2 SLG (PULSE START)	TDR SERIES 400W MH TYPE 2 DIST. SHORT FULL CUTOFF MEETS THE NIGHTTIME FRIENDLY CRITERIA	ONE 400 WATT CLEAR ED28 PULSE START METAL HALIDE IN HORIZONTAL POSITION	TDR_400M_R2_SLG_(PULSE_START).ies	38000	0.72	912


STATISTICS						
Description	Symbol	Avg	Max	Min	Max/Min	Avg/Min
ROADWAY	+	1.9 fc	5.0 fc	0.7 fc	7.1:1	2.7:1

NOTES
1. FIXTURE MOUNTING HEIGHT 40.0 FEET.

LUMINAIRE LOCATIONS										
No.	Label	Location			MH	Orientation	Tilt	X	Aim	
		X	Y	Z					Y	Z
1	A	0.0	39.0	40.0	40.0	0.0	0.0			
2	A	175.0	39.0	40.0	40.0	0.0	0.0			
3	A	350.0	39.0	40.0	40.0	0.0	0.0			
4	A	525.0	39.0	40.0	40.0	0.0	0.0			
5	A	700.0	39.0	40.0	40.0	0.0	0.0			
6	A	875.0	39.0	40.0	40.0	0.0	0.0			
7	A	1050.0	39.0	40.0	40.0	0.0	0.0			



LIGHTING TECHNOLOGY
lighting.tech@lithonia.com
One Lithonia Way
Conyers, GA 30012
P: (800) 279-8043
F: (770) 929-3625

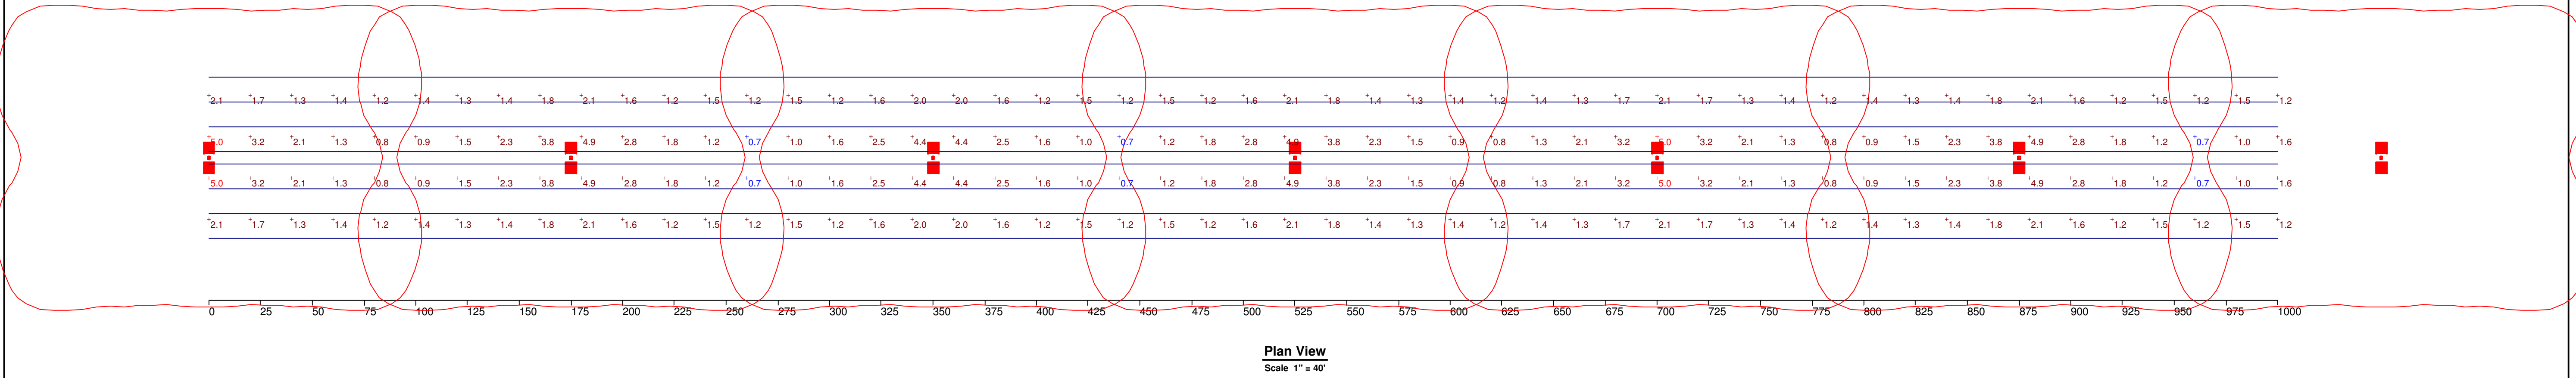

ROADWAY
TYPICAL 6 LANES 1000' SECTION
POINT ILLUMINATION STUDY

Designer
R.A. MCILRATH

Date
JAN. 12, 2010

Scale
AS NOTED

Drawing No.
999-03609E14