


NOTES
 1. FIXTURE MOUNTING HEIGHT 20.0 FEET.

STATISTICS

Description	Symbol	Avg	Max	Min	Max/Min	Avg/Min
ROADWAY	+	1.2 fc	7.4 fc	0.1 fc	74.0:1	12.0:1

LUMINAIRE SCHEDULE

Symbol	Label	Qty	Catalog Number	Description	Lamp	File	Lumens	LLF	Watts
+	A	92	AS2 250S SR4W	ARCHITECTURAL ARM MOUNTED CUTOFF LUMINAIRE WITH SR4W REFLECTOR. Meets the NIGHTTIME FRIENDLY Criteria	ONE 250 WATT CLEAR ET-18 HIGH PRESSURE SODIUM, HORIZONTAL POSITION.	LTL11372.IES	27500	0.81	310

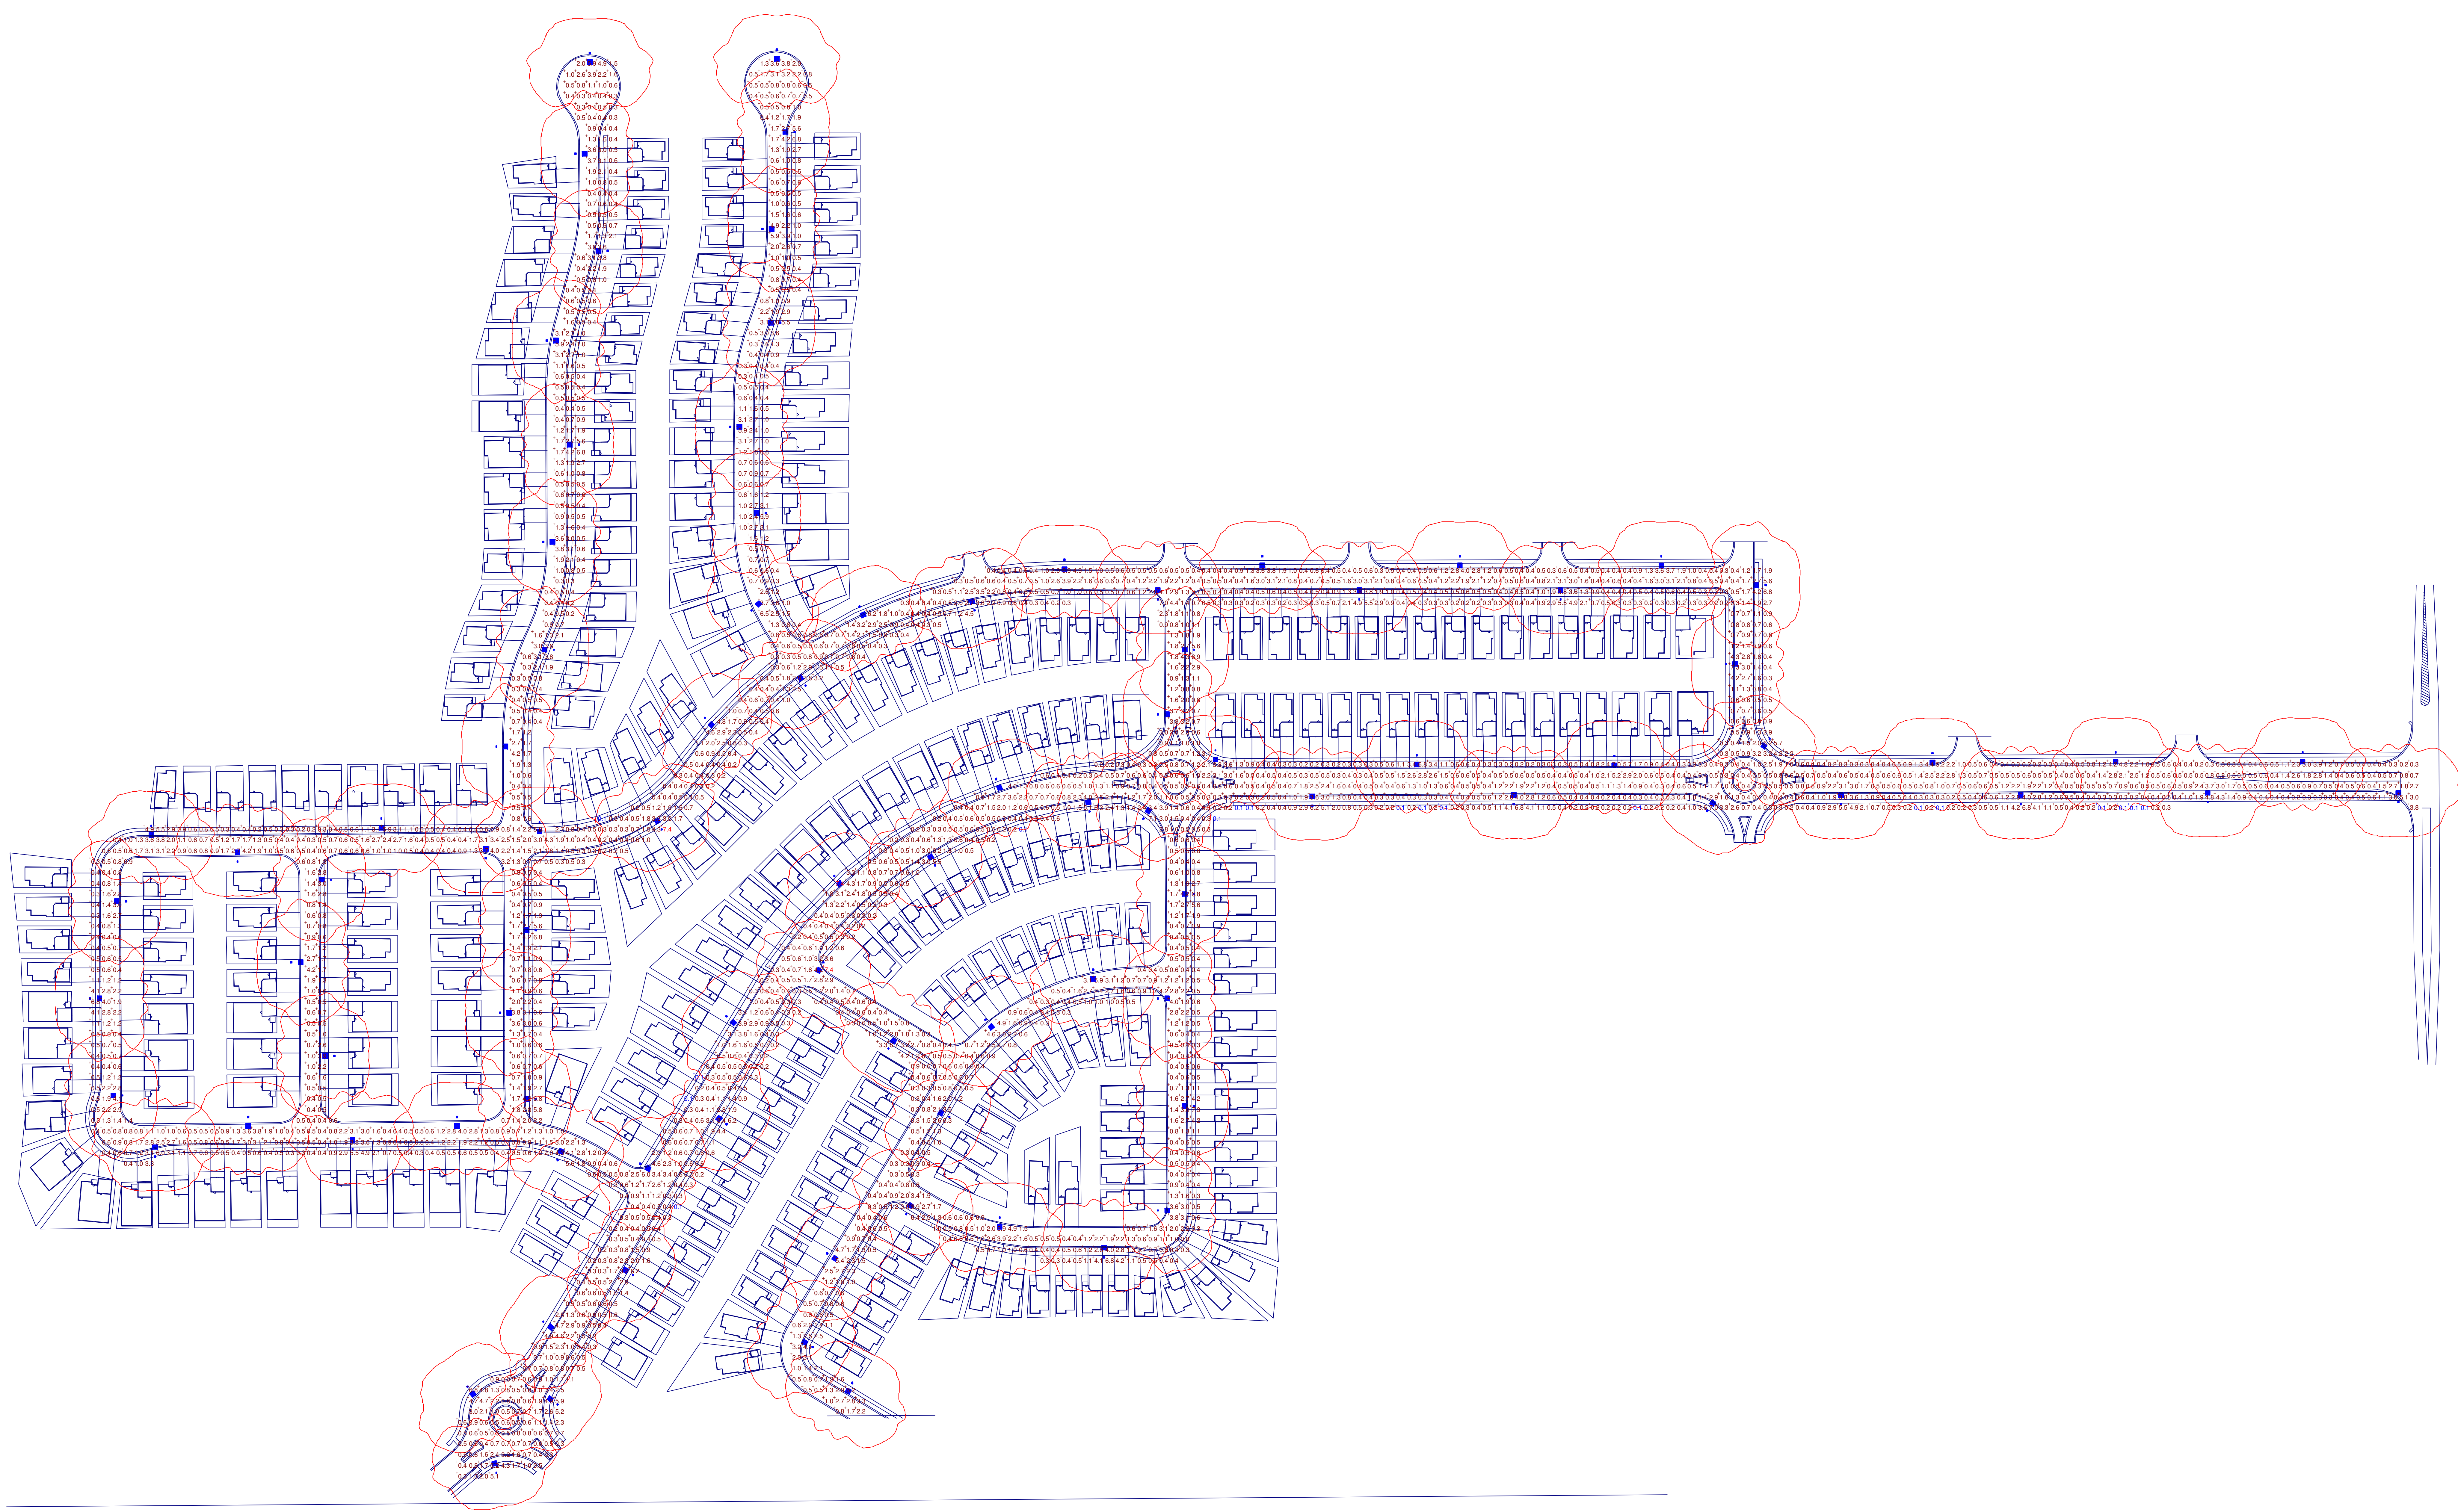

Plan View
 Scale: 1" = 60'