


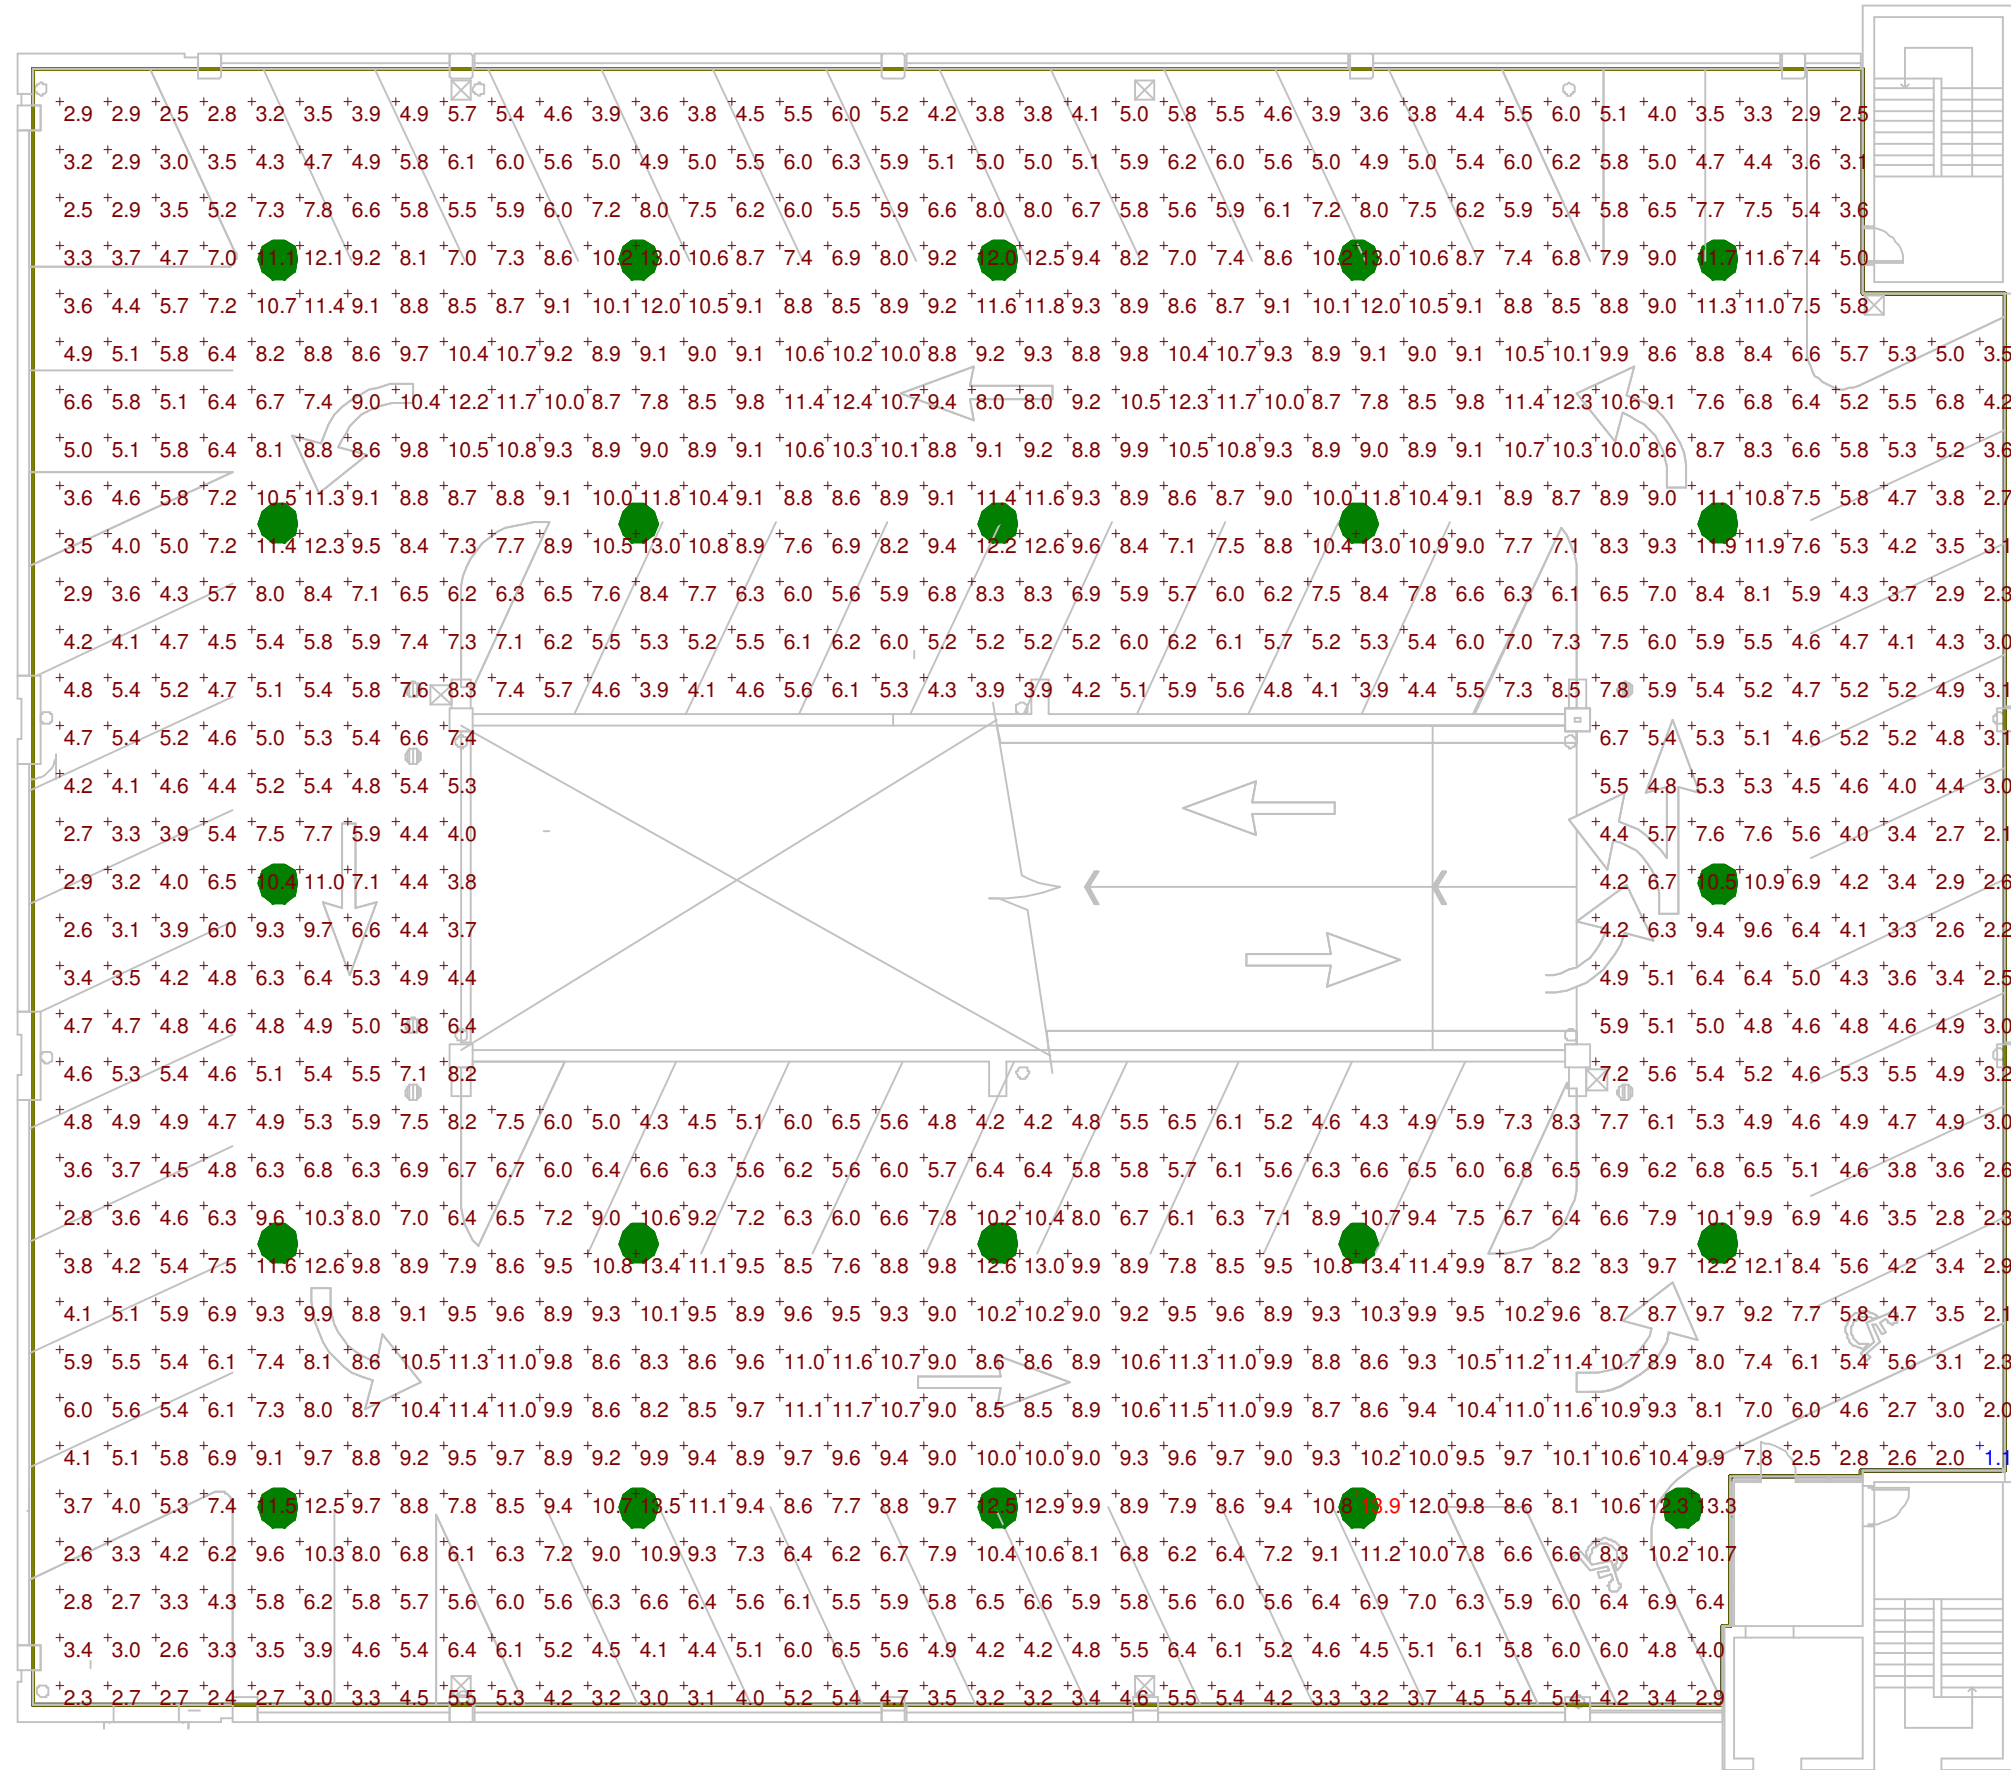
LUMINAIRE SCHEDULE									
Symbol	Label	Qty	Catalog Number	Description	Lamp	File	Lumens	LLF	Watts
	B	22	PGR 150M (PULSE START)	PARKING GARAGE LUMINAIRE WITH RECTANGULAR, CUTOFF DISTRIBUTION.	ONE 150-WATT CLEAR ED17 PULSE START METAL HALIDE, HORIZONTAL POS.	PGR_150M (PULSE_START).ies	14000	0.72	189

STATISTICS						
Description	Symbol	Avg	Max	Min	Max/Min	Avg/Min
area summary@floor	+	7.0 fc	13.9 fc	1.1 fc	12.6:1	6.4:1

NOTES

1. Readings shown are in units of maintained footcandles.
2. Total light loss factor = See luminaire schedule
3. Test plane = 0' aff
4. Ceiling height = 10' aff
5. Fixture mounting height = 8.5' aff
6. Fixture spacing = 30' centers
7. Reflectance = 10/10/10
8. This photometrics layout was calculated using specific criteria, any deviation from stated parameters will effect actual performance.
9. These lighting calculations are not a substitute for independent engineering analysis of lighting system suitability and safety.

POWER DENSITY STATISTICS				
Name	# Luminaires	Total Watts	Area	Density
Power Density Zone # 1	22	4158.00 W	21736.24 ft ²	0.19 W/ft ²



Plan View
Scale 1" = 16'